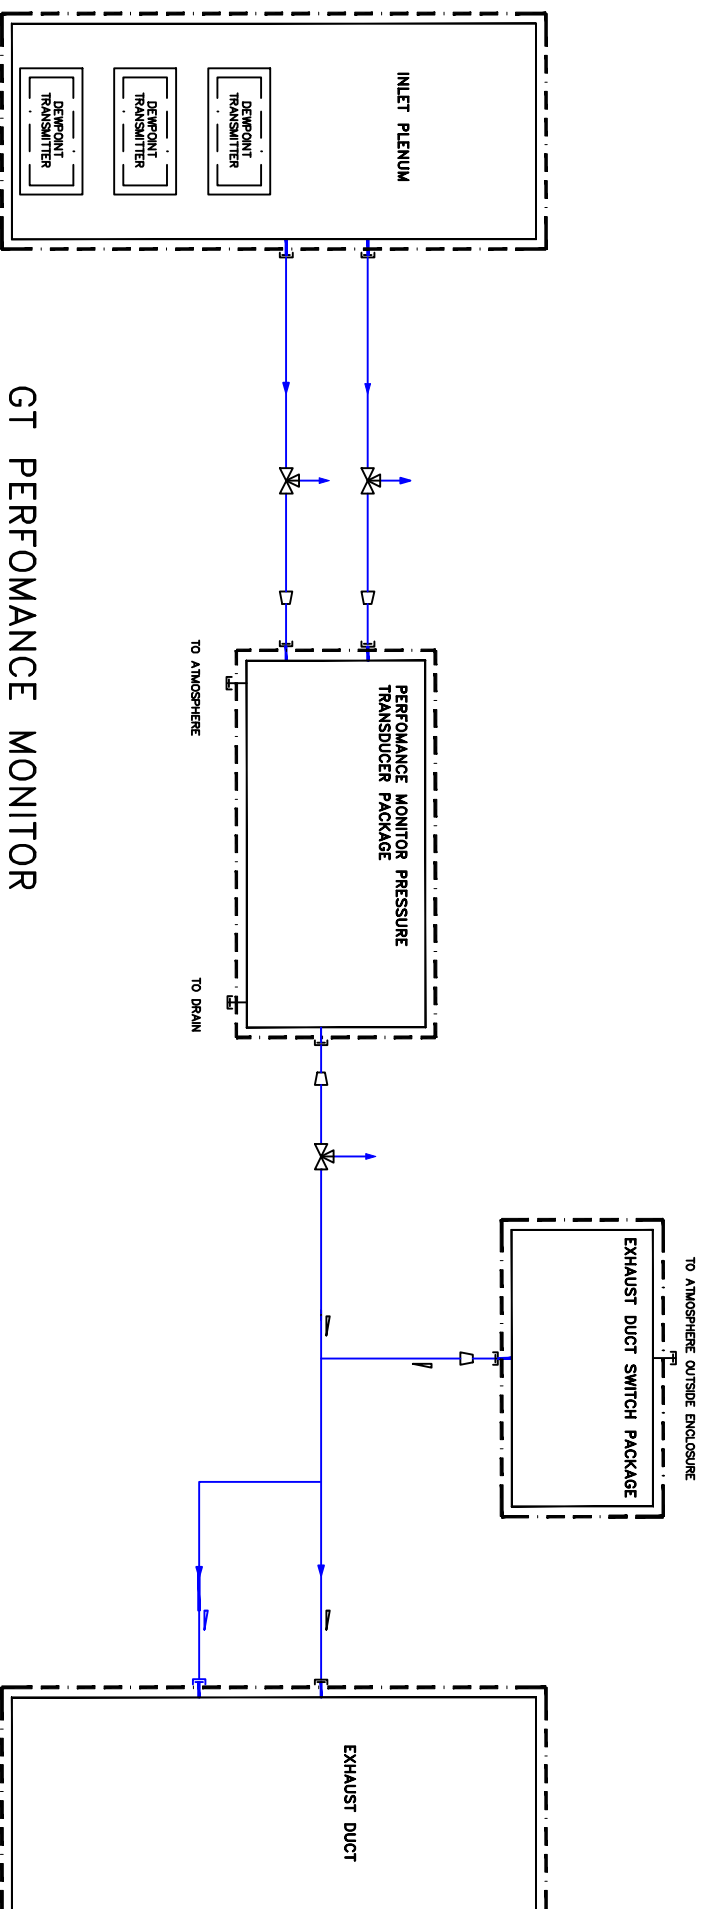
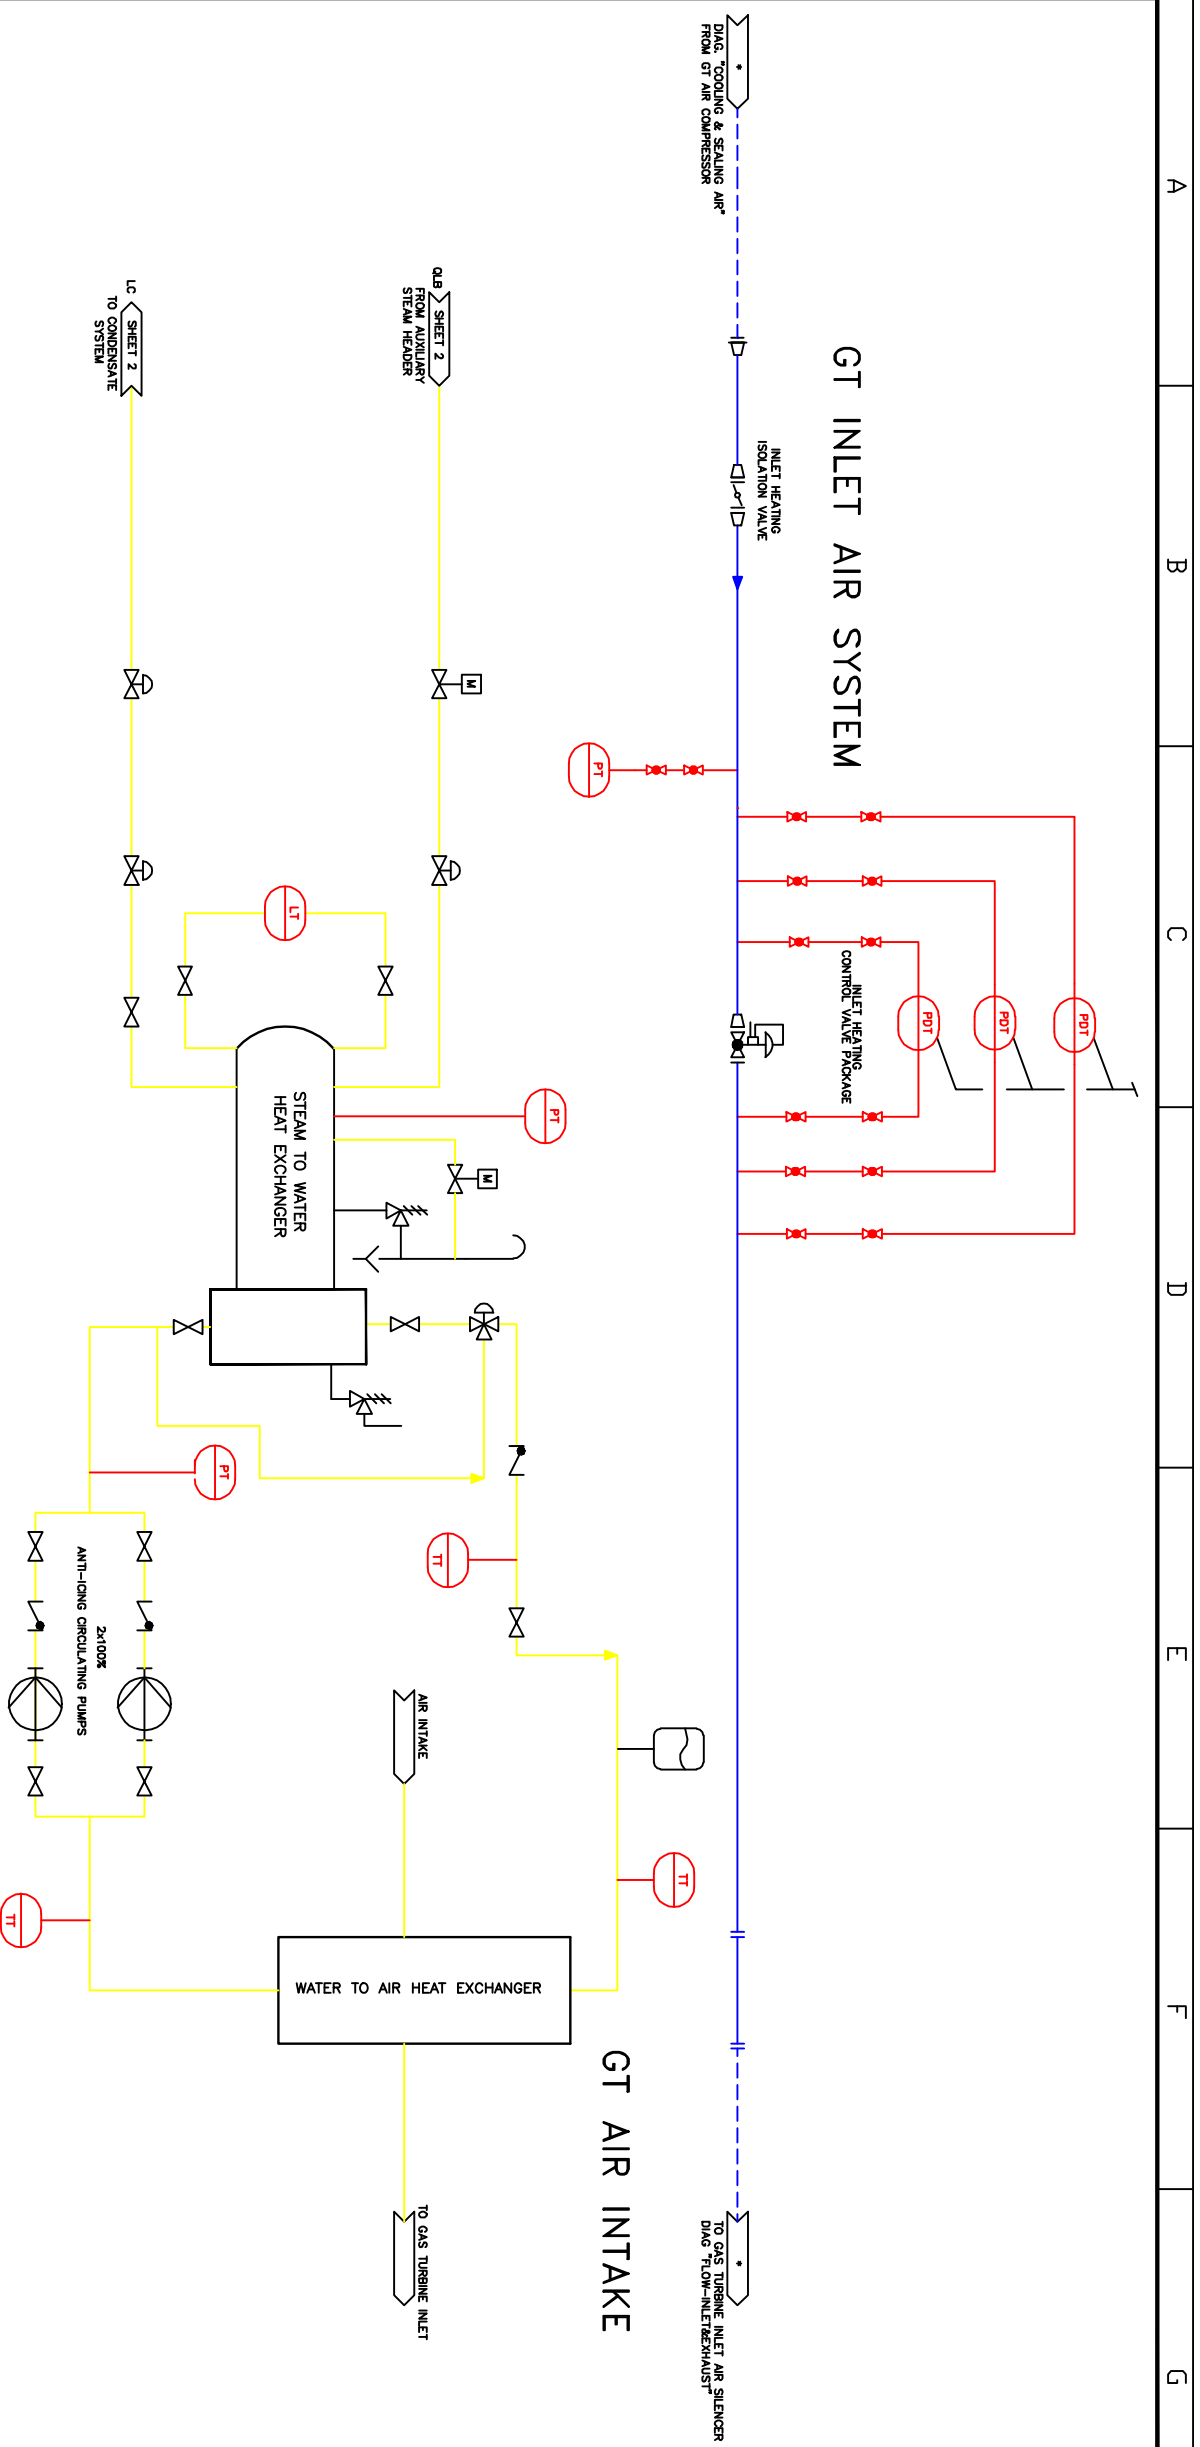


[illegible]**MAIN CONTRACTOR:**

G.E.-COBRA-INTEC

ACION/PROYECTO:
C.C. PP LACQ

ITEM/TITULO:	GT AUXILIARIES SYSTEM P&ID
	

ENERGIA

VALID FOR BID ONLY
This drawing is prepared for conceptual design. The design may be changed during the detailed design stage.

GT AUXILIARIES SYSTEM P&ID										
Scale	Job number/ Job Project	Unit/ Stream	System/ Stream	Doc./Discipline	Doc./Document	Type/Type	Doc. Orig./ Doc. n°	Doc. n°	Sheet number/ n° sheets	Rev
M328/10									1	
Size Project/Project									2	Rev.
Drawn										
	LAC	19	MB	MD	IE	MO	01	2	D	