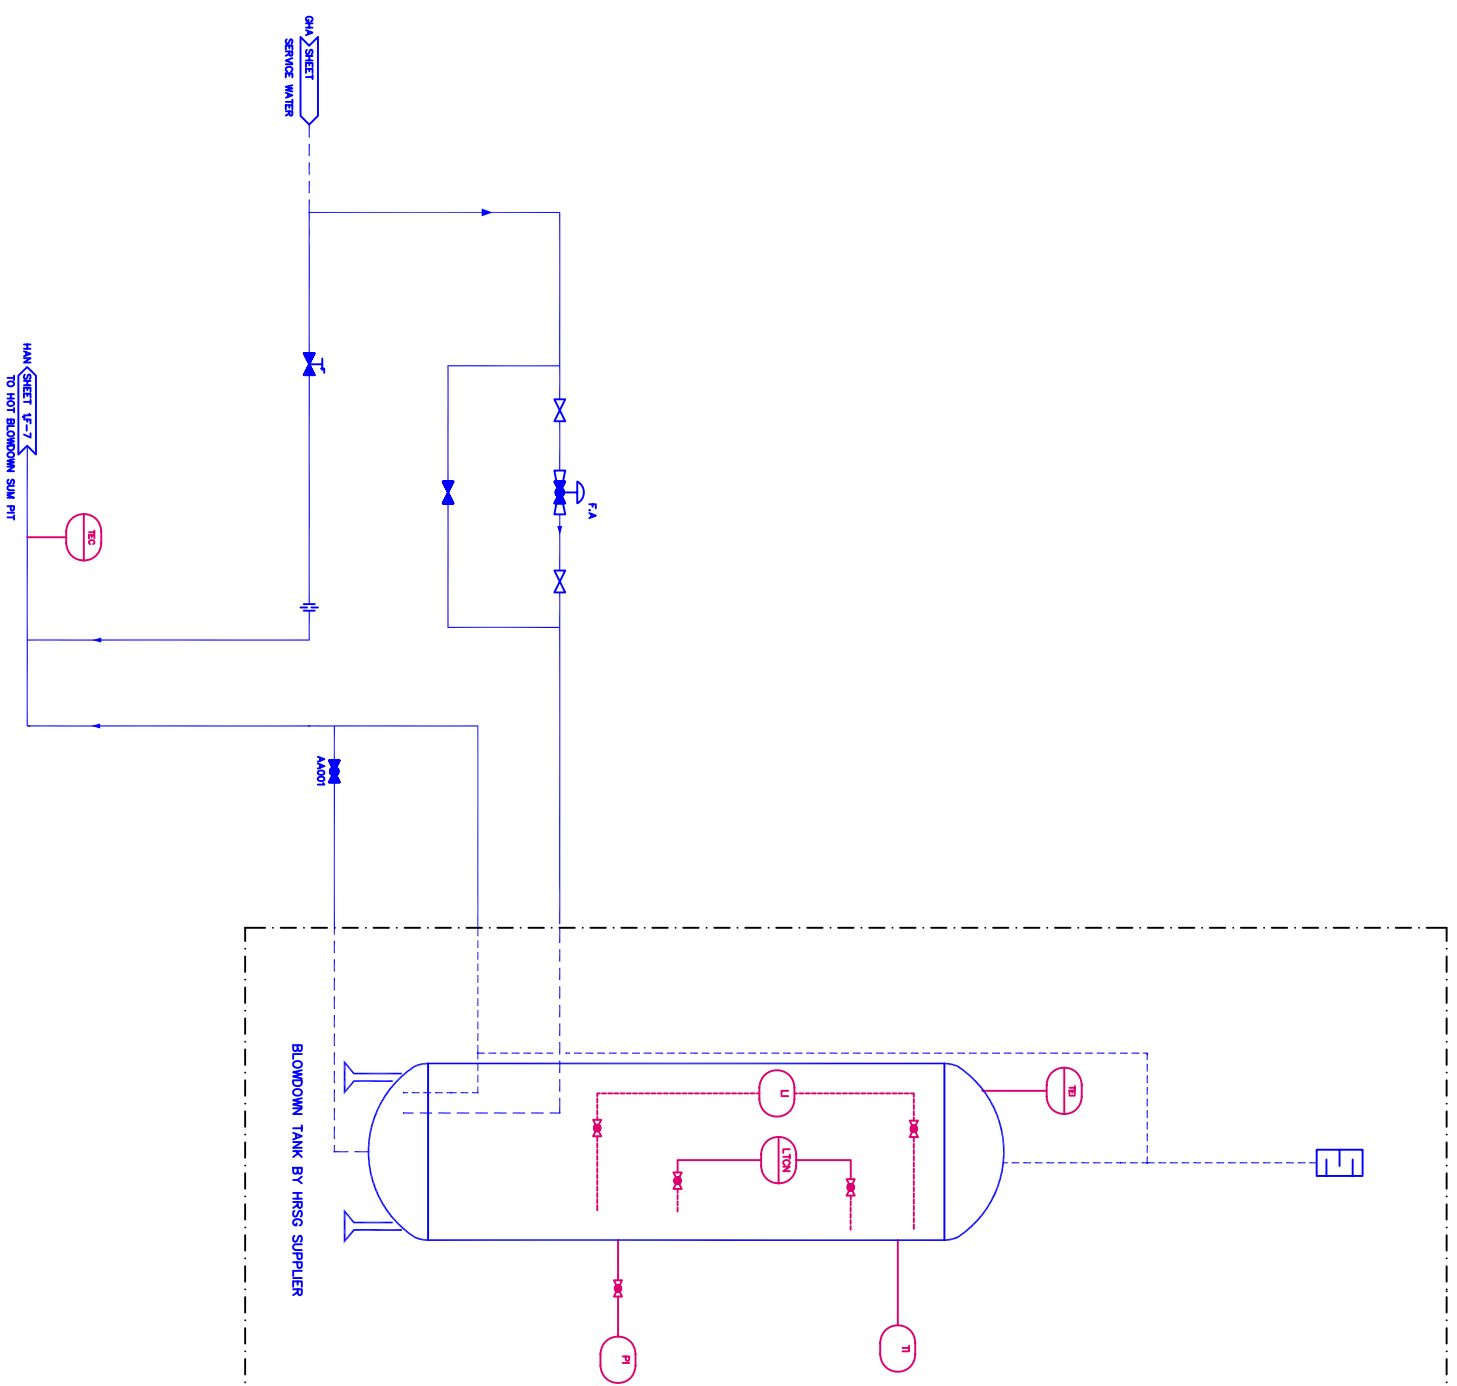


[illegible]

ENDESA FRANCE

MAIN CONTRACTOR:
G.E.-COBRA-INTEC

JOB DESCRIPTION/PROTECTO:
C.C. PP LACQ

MTC					
Energia					
PLANT DRAINS SYSTEM P&ID					
MTC/MDC:					
Scales	JOB number/ Job Project	Lark/ United	System/ Scheme	Type	Dwg. No./ Ext. Extension
A3/B8 /A10					

VALID FOR BID ONLY
This drawing is prepared for conceptual design. The design may be changed during the detailed design stage.

ESTE PLANO ES PROPIEDAD DE DATITEC PROHIBIDA SU REPRODUCCION