


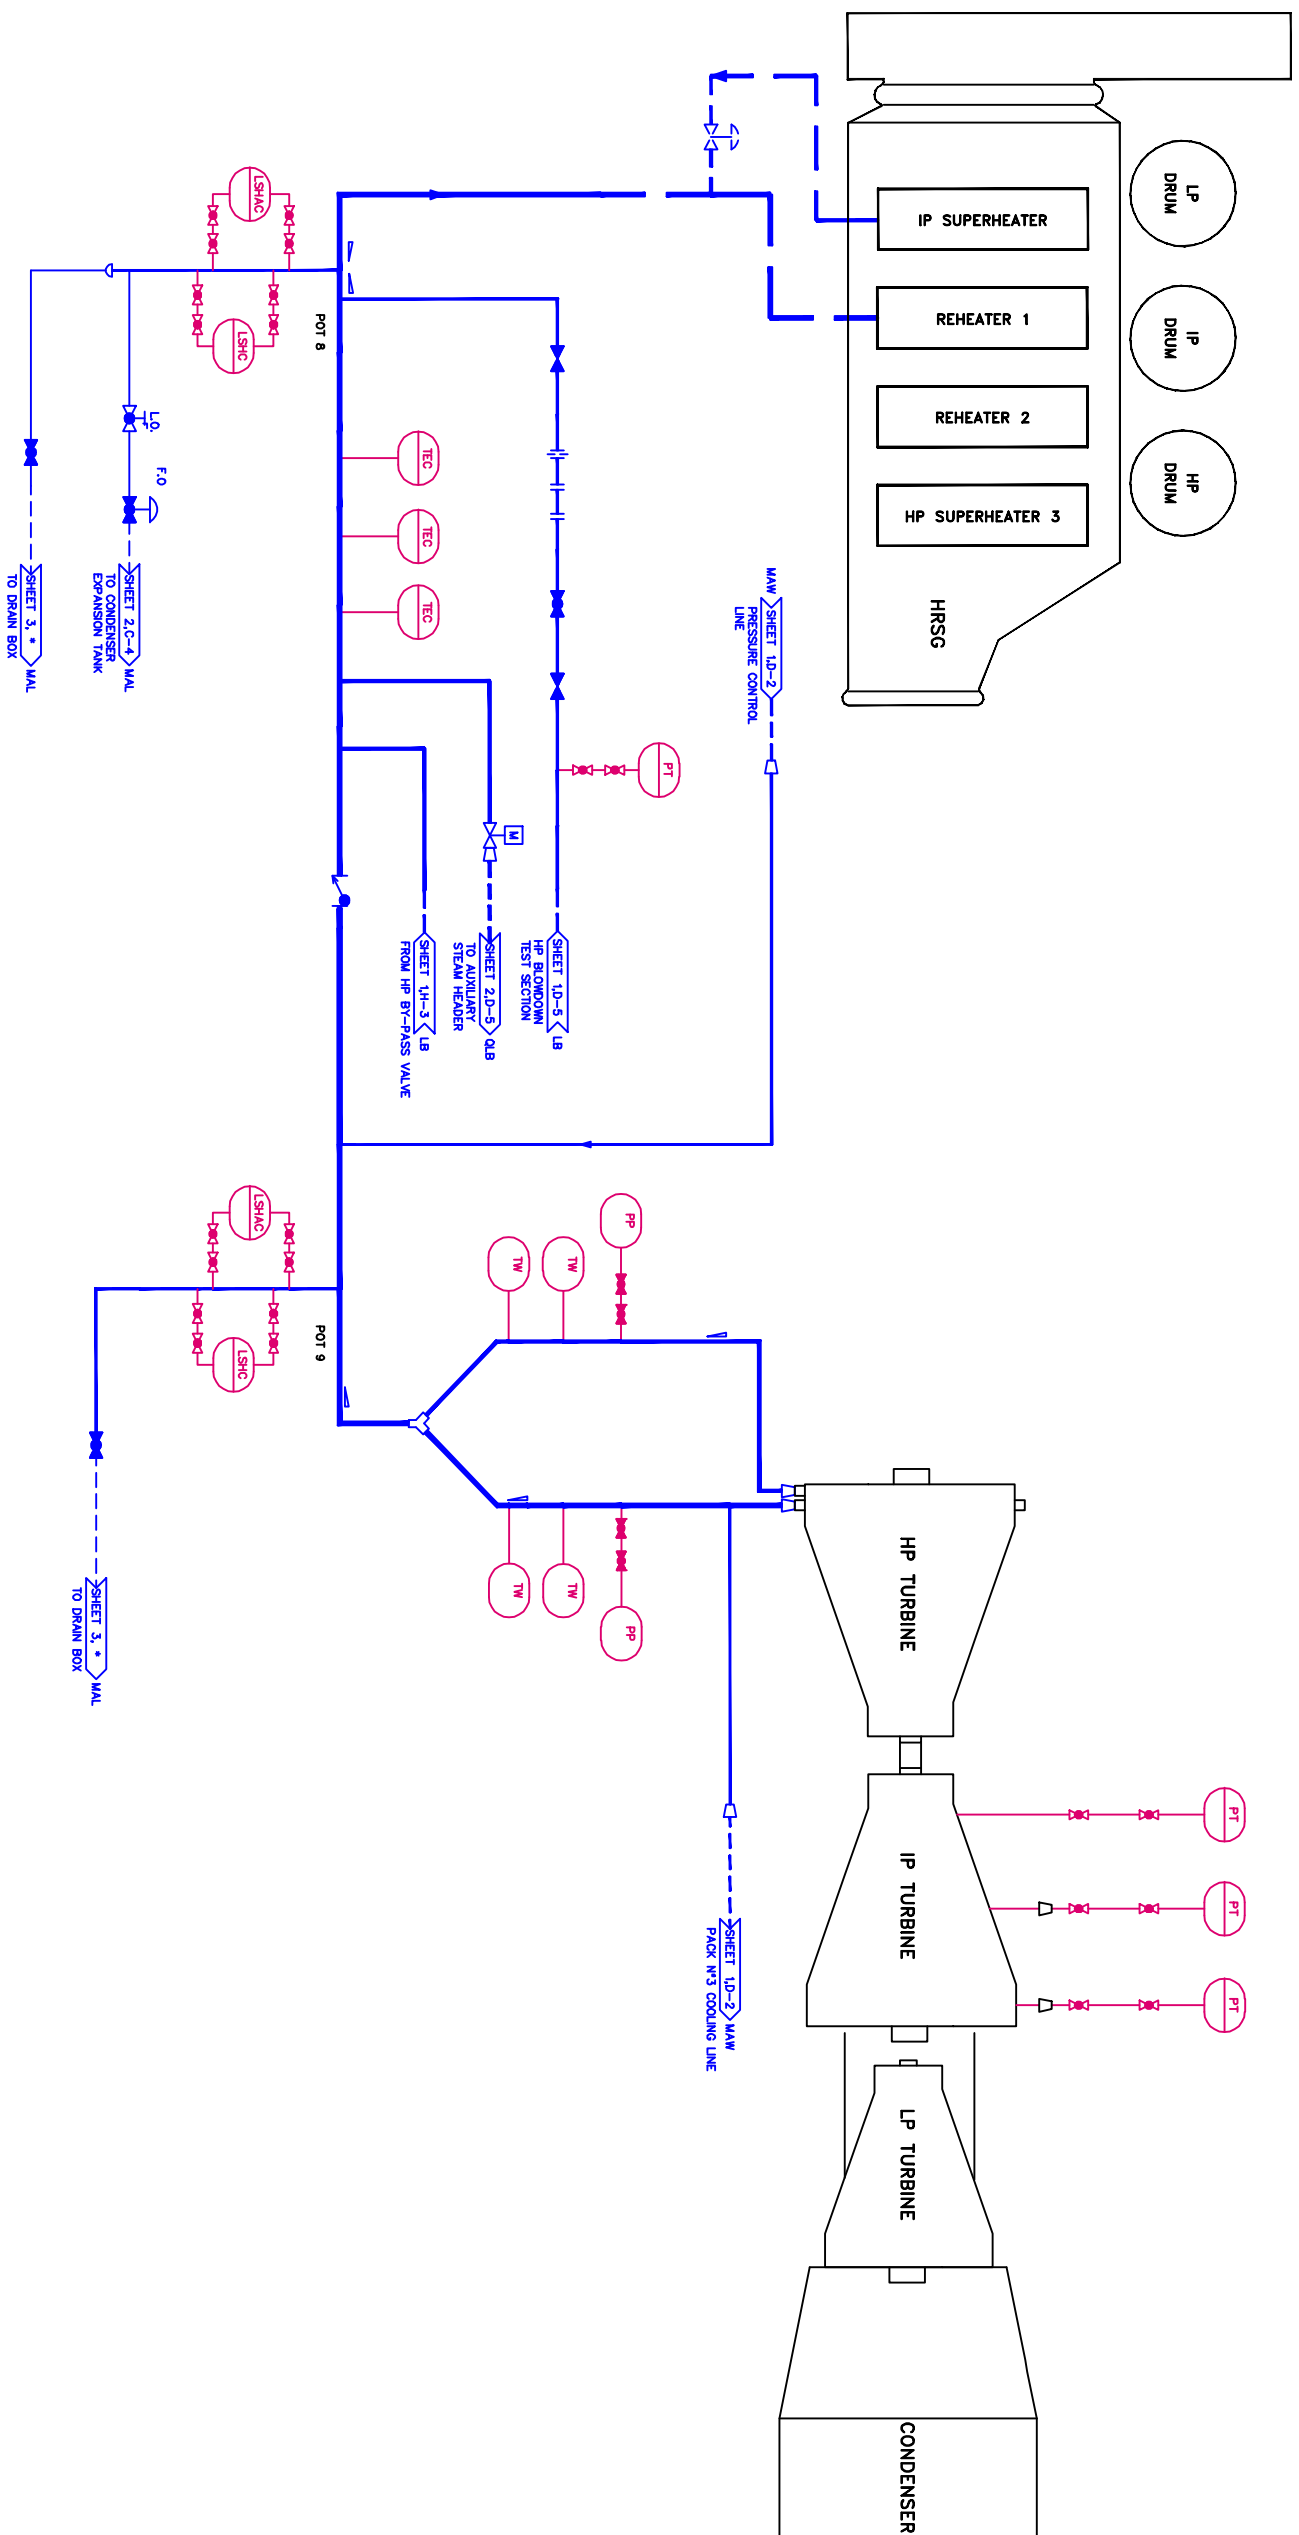

	B	INCLUDED G.E. COMMENTS	14-04-08	F.A.H.			J.B.A.		
A	FOR G.E. & COBRA COMMENTS		23-11-07	F.A.H.			D.C.P.		
Rev.	Description/Object as it exists	Date/Time	Prep./Revised	Wkr./Comp.	O/C/Schedule	Appr./Dy/Dwg			

ENDESA FRANCE

MAIN CONTRACTOR: G.E.-COBRA-INTEC

JOB DESCRIPTION/PROYECTO:	C.C. PP LUCY
---------------------------	--------------


INTEC
Energia

IP/COLD REHEAT STEAM SYSTEM P&ID

Scale	Job number/ n° Projecto	Unit/ Unidad	System/ Sistema	Discipline	Doc. Orig./ Ech. Emisión	Doc. n°	Sheet number/ n° página	Free
1:1000 1/10							7	

VALID FOR BID ONLY
This drawing is prepared for conceptual design. The design may be changed during the detailed design stage.

DNM1	LUC	19	L	B	M	D	D	I	E	M	0	0	1	4	B
	ESTE PLANO ES PROPIEDAD DE INITEC. PROHIBIDA SU REPRODUCCION														