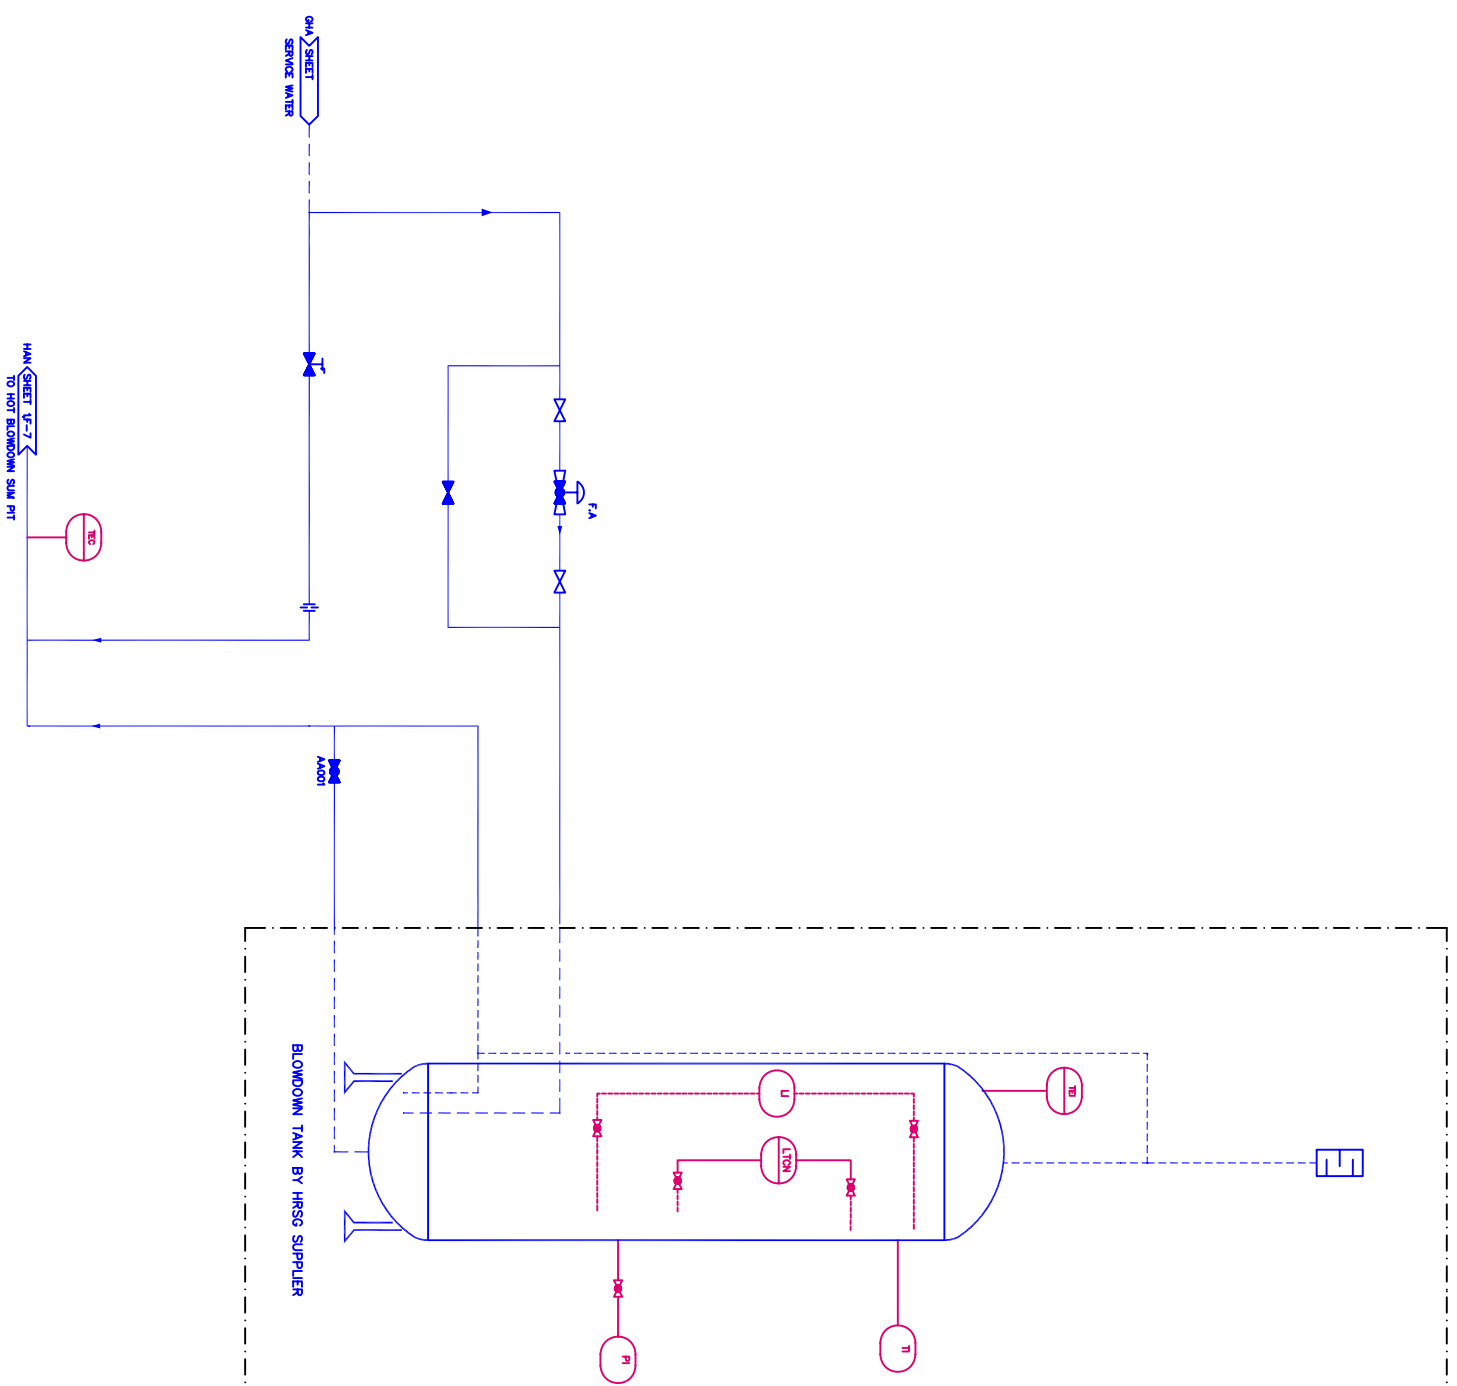


[illegible]

ENDESA FRANCE

MAIN CONTRACTOR:	
------------------	--

G.E.-COBRA-INTEC

	JOB DESCRIPTION/PROYECTO: C.C. PP LUCY
--	---

PLANT DRAINS SYSTEM P&ID					
TITLE/MOD:					
Scale	Job number/ Project	Unit/ Location	System/ Stream	Phase	Drawn by Date
M208 / L10					



VALID FOR BID ONLY
This drawing is prepared for conceptual design. The design may be changed during the detailed design stage.

ESTE PLANO ES PROPIEDAD DE DATTECC PROHIBIDA SU REPRODUCCION